

Planning Received 7/11/23

**Seger** architects, inc  
 83 North Street  
 Salem, Massachusetts 01970  
 Telephone: 978-744-0208  
 www.segerarchitects.com

PROJECT ARCHITECT  
 SEAL

PROJECT CONSULTANTS


**UNITED HVAC**  
 333 Weymouth Street,  
 Rockland, MA

PROJECT INFORMATION  
 OWNER INFORMATION

No.	Description	Date

Job No.: 2020-011  
 Date: July 6, 2023  
 Scale: As Noted  
 Designed By: DR  
 Drawn By: JM  
 Checked By: JAS  
 Approved By: JAS  
 Copyright © by Seger Architects, Inc. All rights reserved.

**Proposed First Floor Key Plan**  
 SHEET NAME  
**A-0.2**  
 SHEET NO.

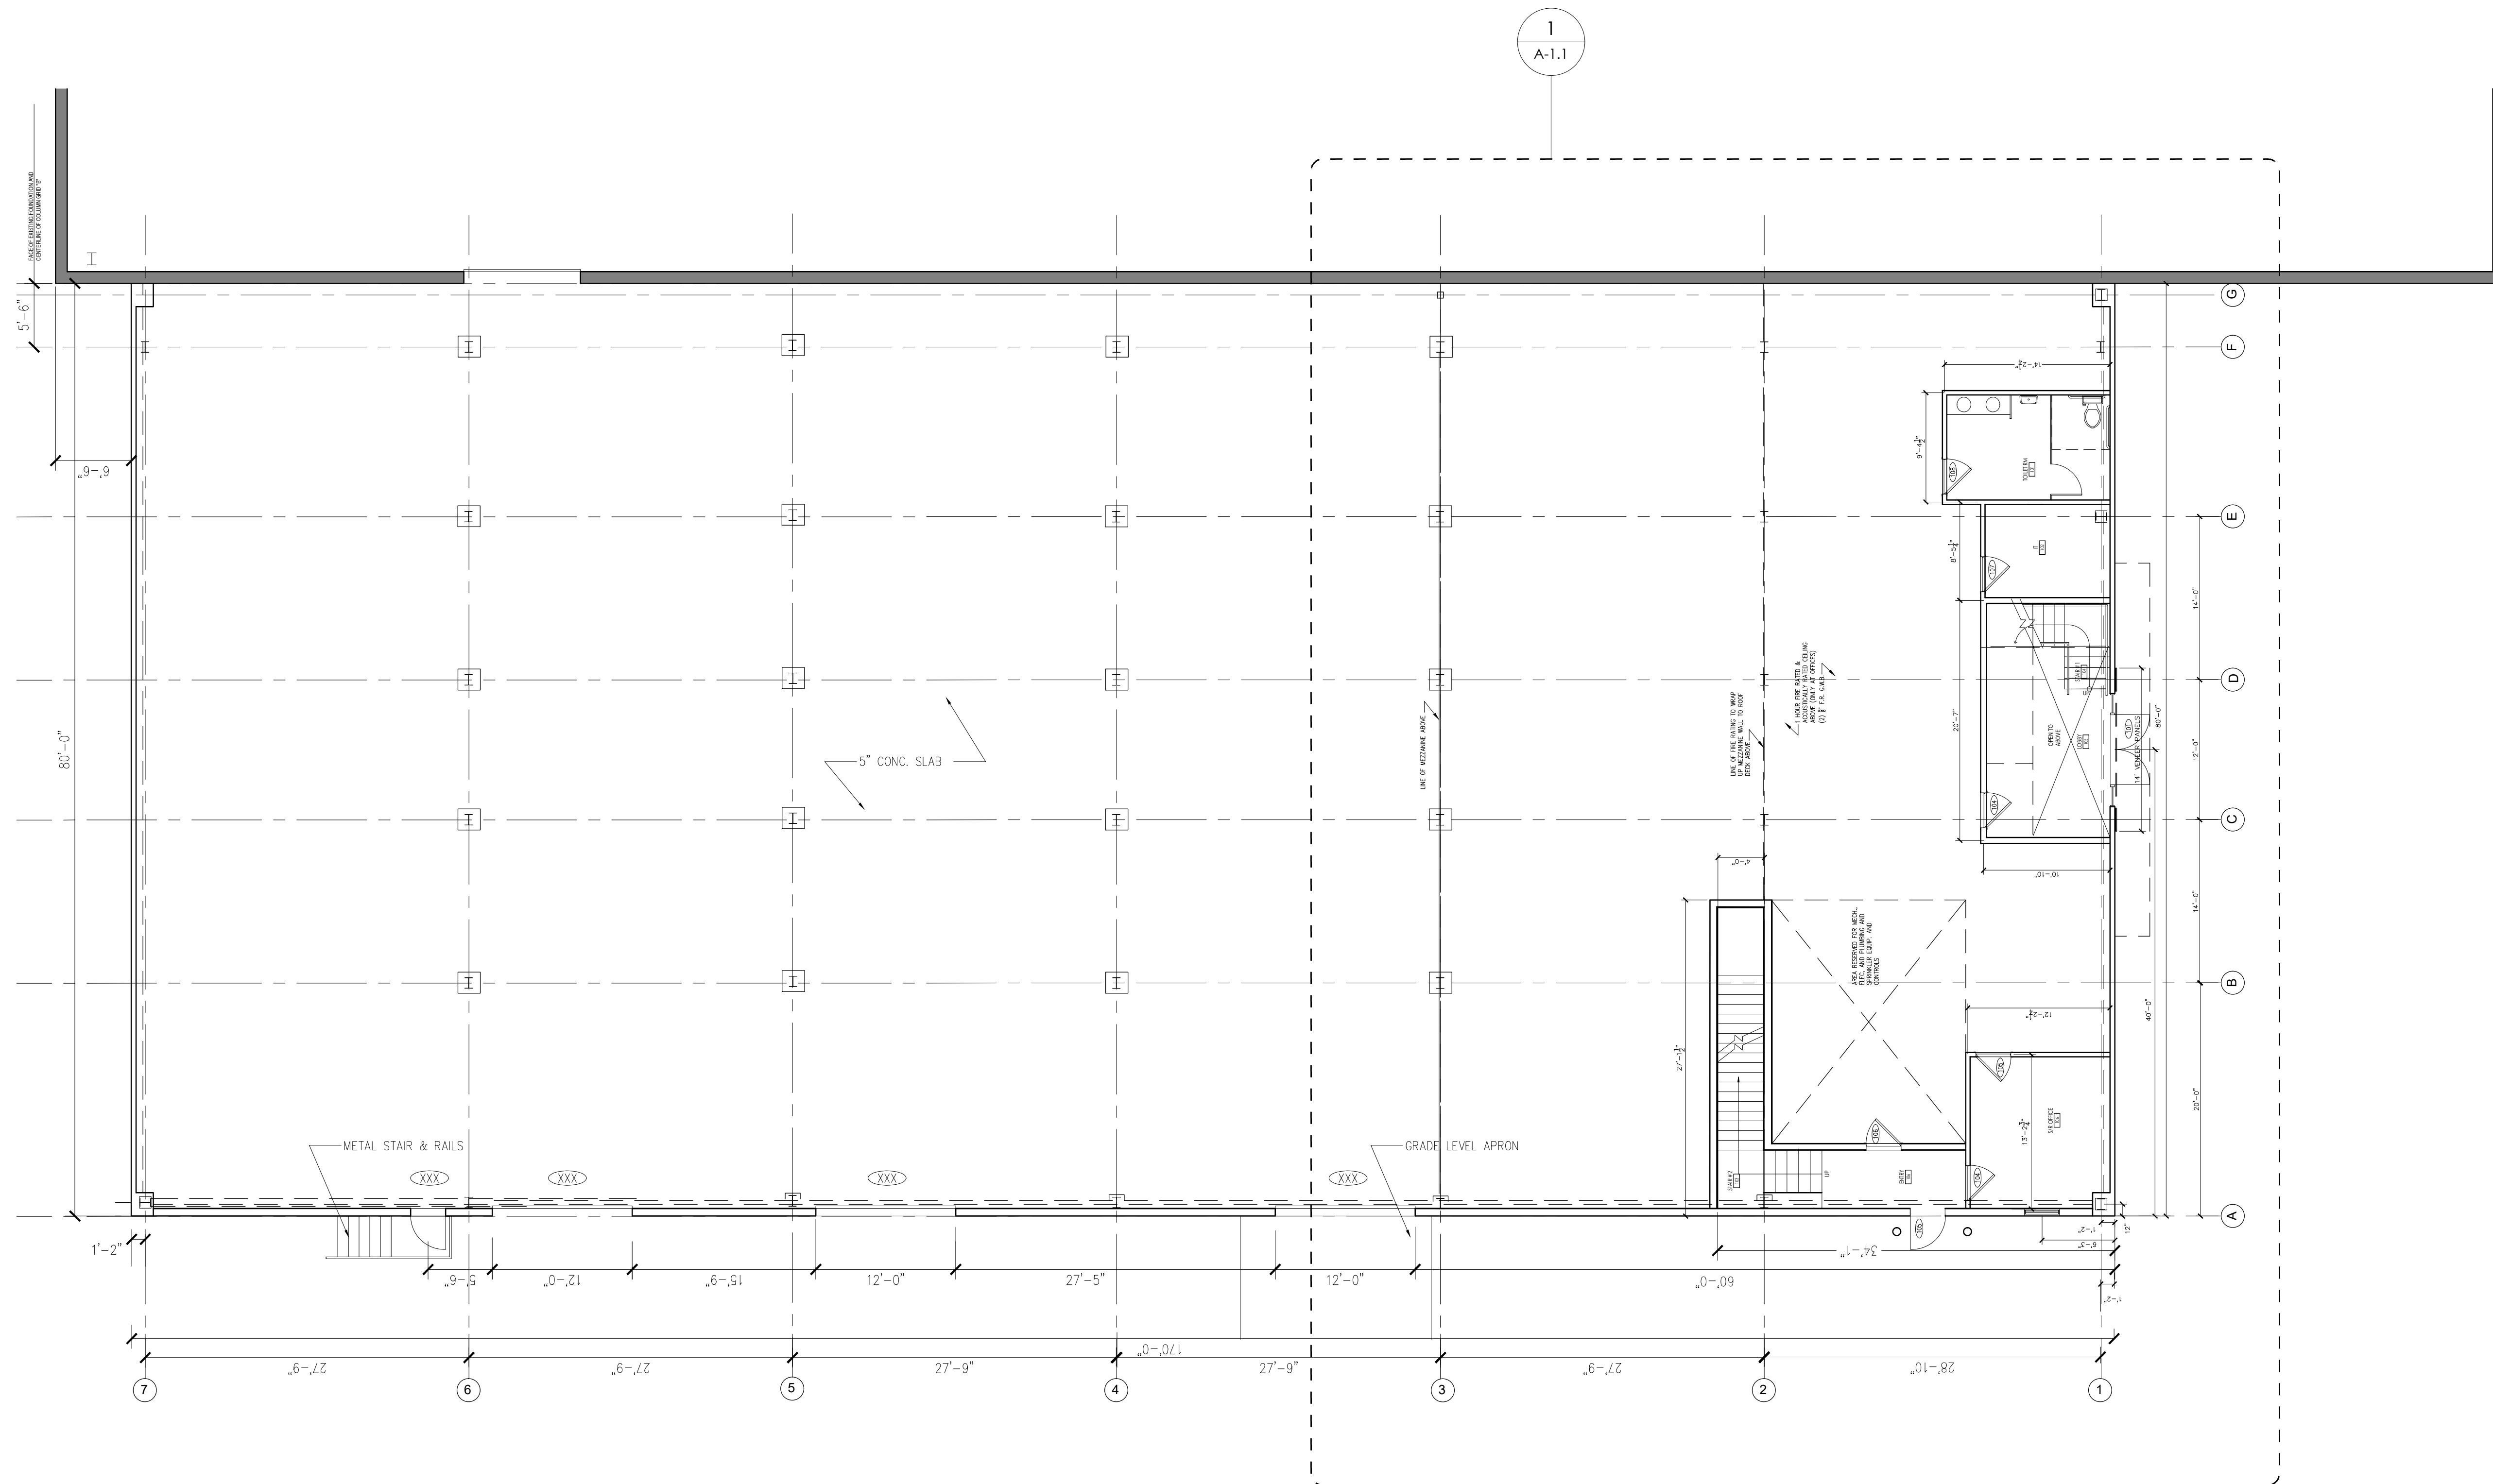

**1 First Floor Plan**  
 SCALE: 1/8"=1'-0"

**UNITED  
 HVAC**


333 Weymouth  
 Street,  
 Rockland, MA

No.	Description	Date
PROJECT REVISIONS		

Job No.:	2020-011
Date:	July 6, 2023
Scale:	As Noted
Designed By:	DR
Drawn By:	JM
Checked By:	JAS
Approved By:	JAS
Copyright © by Seger Architects, Inc. All rights reserved.	

**Proposed  
 Mezzanine  
 Key Plan**

**A-0.3**

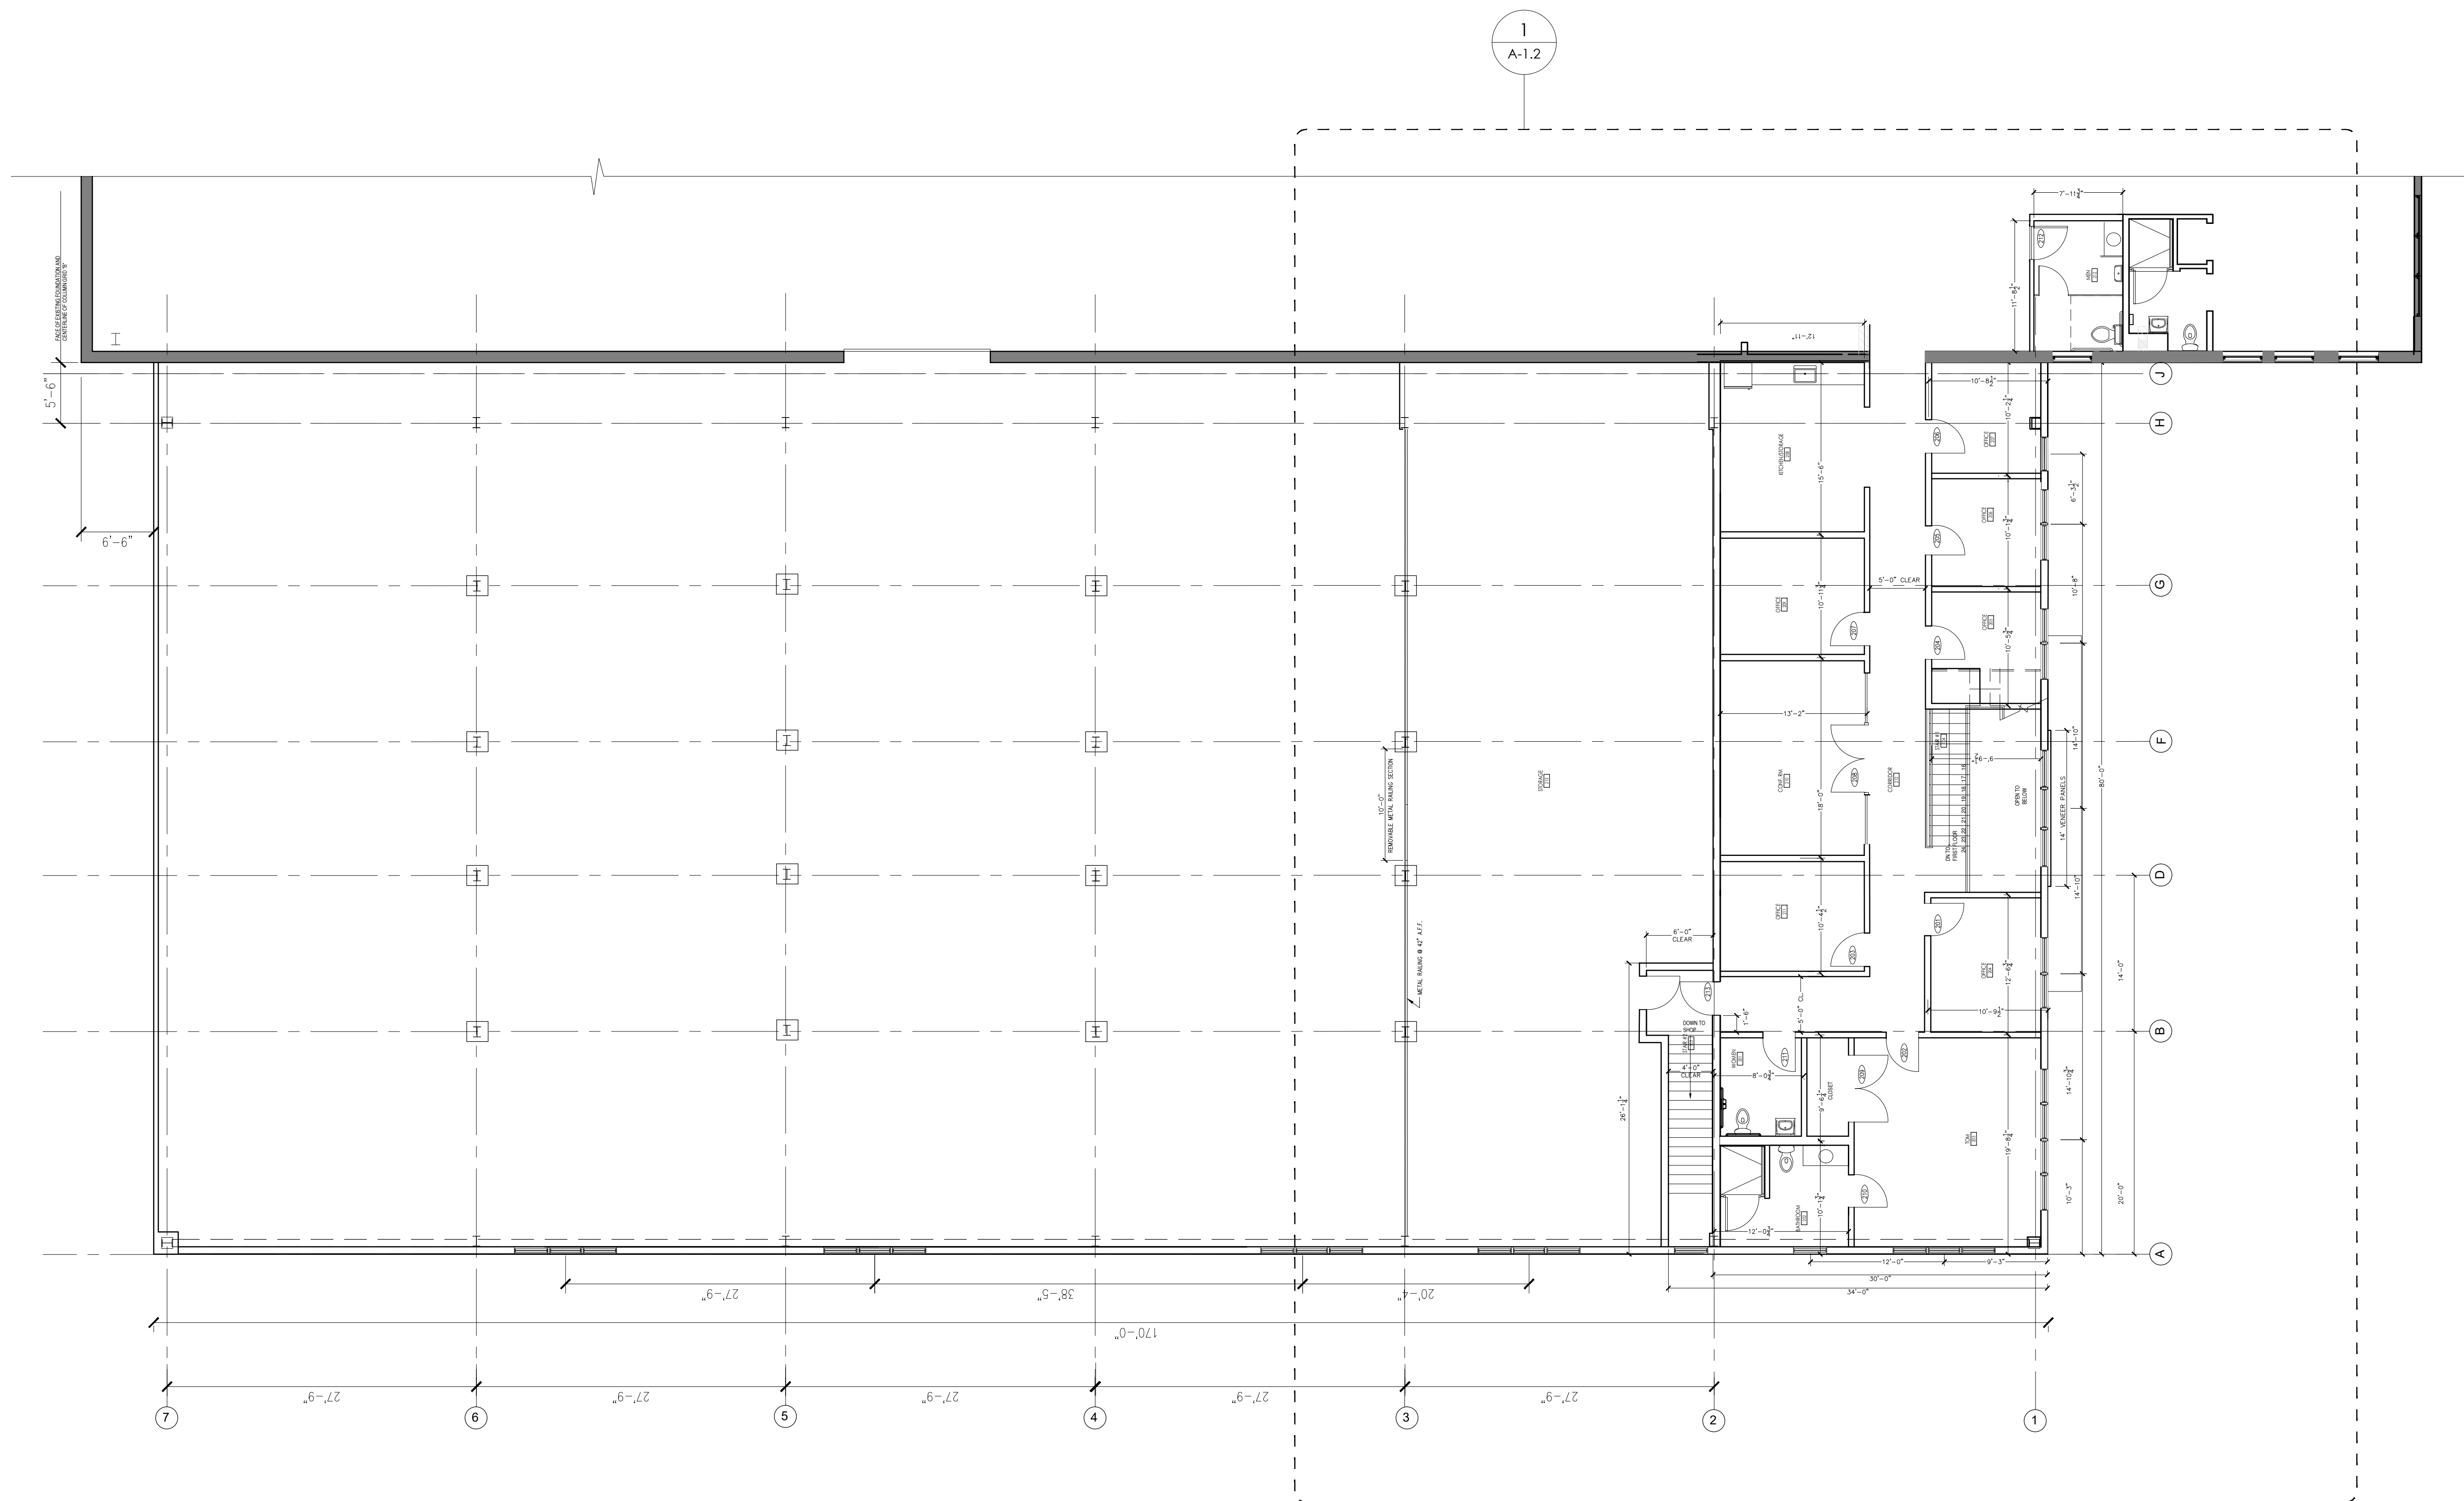

**1 Mezzanine Floor Plan**  
 SCALE: 1/8"=1'-0"

